

# KARAPIRO HEALTH SPA

1002, Highway 1, Karapiro (Chalet B) *Units 1-33*

Approved Waipa District Council  
Building Department

Officer: *S Lewis* Date: *15-5-07*  
Subject to Conditions of  
Building Consent No.

APPLICATION FOR BUILDING CONSENT - 17 / 4 / 2007

*\* Amend sink location*

## ARCHITECTURAL DRAWING

- A301a - Ground Floor Plan (Chalet Type B)
- A301b - Comparison for Original and latest floor plan  
(Chalet Type B)
- A302 - Elevations (Chalet Type B)
- A303 - Sections (Chalet Type B)
- A304 - Details (Chalet Type B)
- A305 - Bracing and Roof Framing Plan (Chalet Type B)
- A306 - Electrical Plan (Chalet Type B)
- A307 - Door and Window Schedules (Chalet Type B)

**JIREH**  
DESIGN LTD [www.ttay.com](http://www.ttay.com)

**TONY TAY GROUP**

LEVEL 1, 540 GT SOUTH ROAD, GREENLANE. PO BOX 68220 NEWTON  
AUCKLAND, NZ PHONE: + 64 9 580 1750 FAX: + 64 9 580 3180

 








Status	Revision
BC	0



Rev	Description of Revision	By	Chk	Date
-----	-------------------------	----	-----	------

**TONY TAY GROUP BUILDING**  
LEVEL 1, 540 GT SOUTH ROAD, GREENLANE. PO BOX 68220 NEWTON  
AUCKLAND, NZ PHONE: + 64 9 580 1750 FAX: + 64 9 580 3180

TONY TAY GROUP

KARAPIRO HEALTH SPA  
SINGLE CHALET


Drawing Title  
CHALET TYPE B  
Comparison for original and  
latest floor plan

Scales	
1:50@A1	1:100@A3


Job No.	Drawing No.
	A301b

Drawn	Checked	Issue Date 17/4/2007
Status BC	Revision 0	




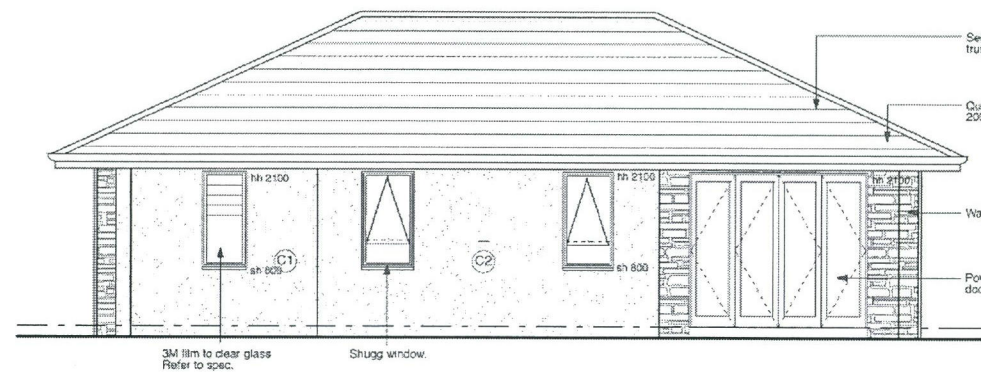


ELEVATION 1 / A.02.02

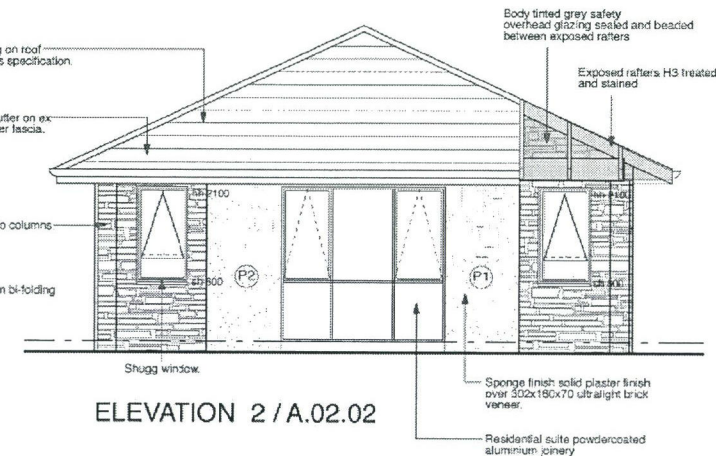

ELEVATION 2 / A.02.02

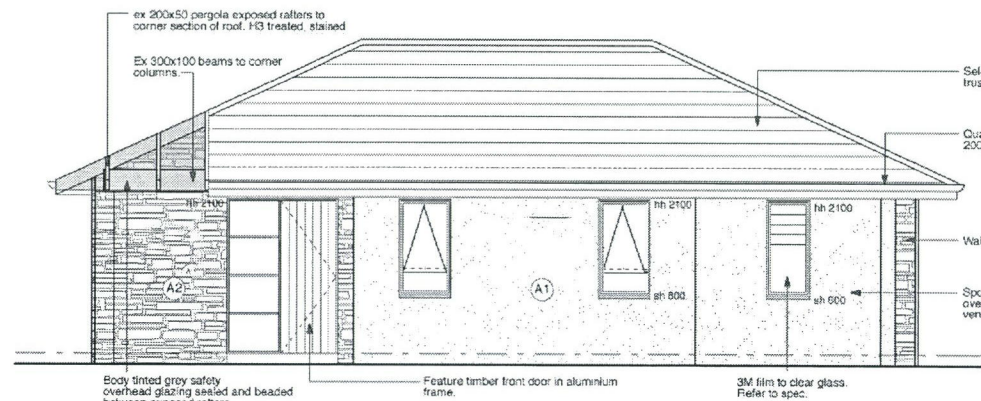

ELEVATION 3 / A.02.02

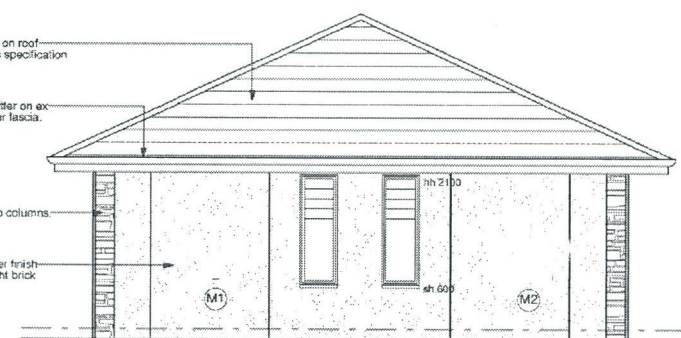

ELEVATION 4 / A.02.02

Rev	Description of Revision	By	Chk	Date
-----	-------------------------	----	-----	------



TONY TAY GROUP BUILDING  
LEVEL 1, 540 GT SOUTH ROAD, GREENLANE, PO BOX 68220 NEWTON  
AUCKLAND, NZ PHONE: + 64 9 580 1750 FAX: + 64 9 580 3180

Client  
TONY TAY GROUP

Job  
KARAPIRO HEALTH SPA  
SINGLE CHALET


Drawing Title  
CHALET TYPE B  
Elevations

Scales  
1:50@A1 1:100@A3

Job No. Drawing No.  
A302

Drawn Checked Issue Date  
17/4/2007

Status Revision  
BC 0

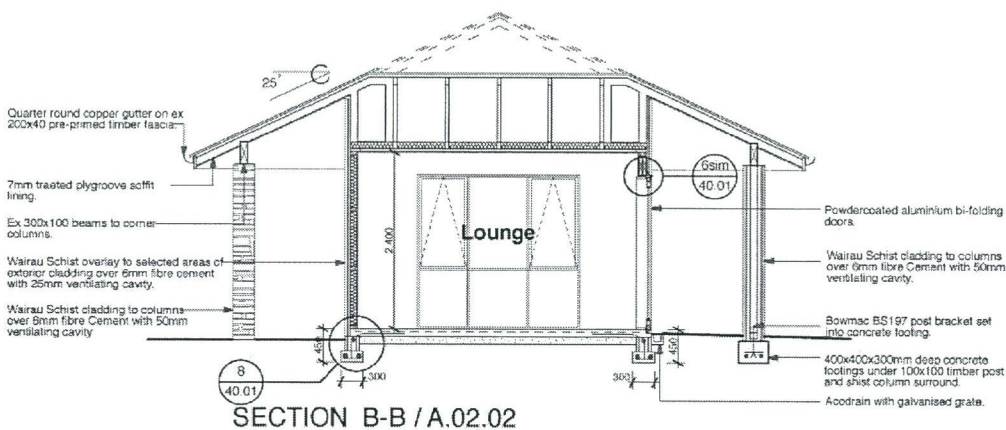[illegible]

Rev	Description of Revision	By	Chk	Dat
-----	-------------------------	----	-----	-----

**JIREH**  
DESIGN LTD [www.ttay.com](http://www.ttay.com)

**TONY TAY GROUP BUILDING**  
LEVEL 1, 540 GT SOUTH ROAD, GREENLANE. PO BOX 68220 NEWTON  
AUCKLAND, NZ PHONE: +64 9 580 1750 FAX: +64 9 580 3111

Client	
--------	--

TONY TAY GROUP

Job	Rate	Time	Cost
Job 1	10	10	100
Job 2	10	10	100
Job 3	10	10	100
Job 96	10	10	100
Job 97	10		

KARAPIRO HEALTH SPA  
SINGLE CHALET


Drawing Title  
CHALET TYPE B  
Sections

Scales	
1:50@A1	1:100@A3


Job No.	Drawing No.
	A303

Drawn	Checked	Issue Date 17/4/2007
Status BC		Revision 0




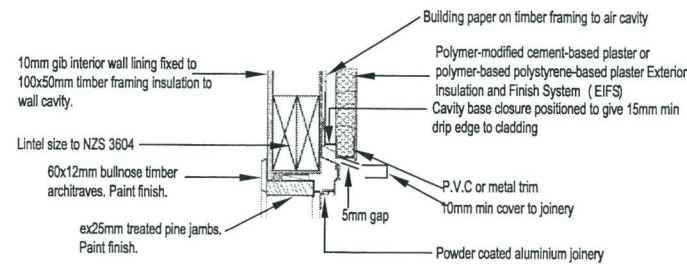


1 HEAD DETAIL  
04.01 Scale 1:10

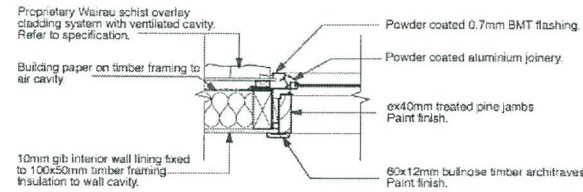


5 JAMB DETAIL  
- Scale 1:10

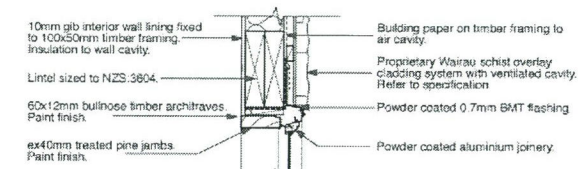


6 sim HEAD DETAIL  
04.01 Scale 1:10

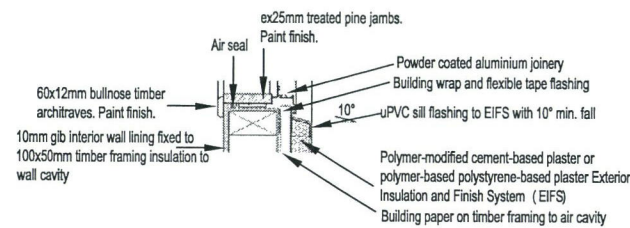


2 SILL DETAIL  
04.01 Scale 1:10

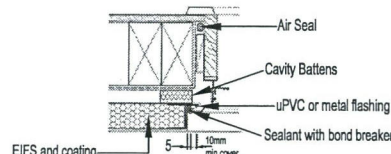


4 JAMB DETAIL  
- Scale 1:10

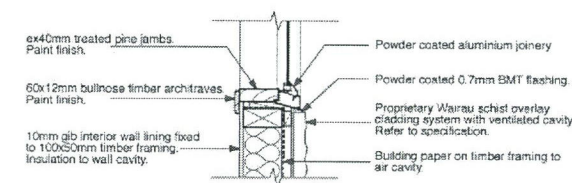

7 SILL DETAIL  
- Scale 1:10

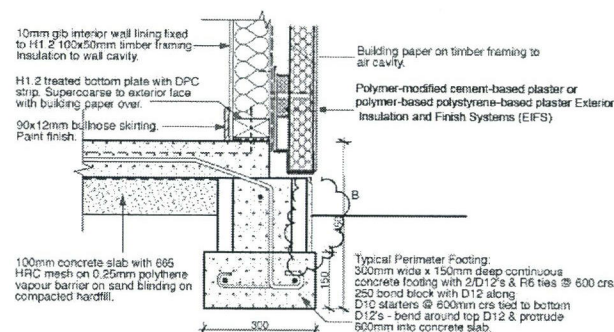

3 FOOTING DETAIL  
04.01 Scale 1:10

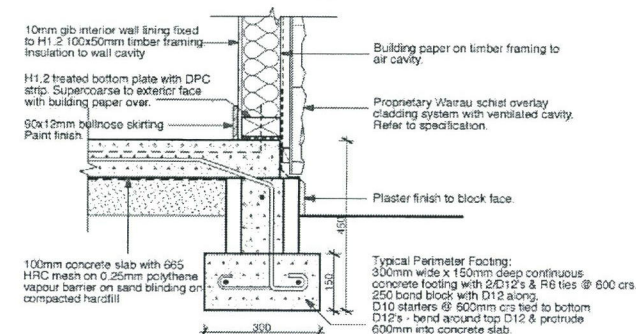

8 FOOTING DETAIL  
04.01 Scale 1:10

Rev	Description of Revision	By	Chk	Date
-----	-------------------------	----	-----	------

**JIREH**  
DESIGN LTD [www.ttay.com](http://www.ttay.com)

**TONY TAY GROUP BUILDING**  
LEVEL 1, 540 GT SOUTH ROAD, GREENLANE, PO BOX 68220 NEWTON  
AUCKLAND, NZ PHONE: + 64 9 580 1750 FAX: + 64 9 580 3180

Client

TONY TAY GROUP

Job

KARAPIRO HEALTH SPA  
SINGLE CHALET

Drawing Title

CHALET TYPE B  
Details

Scales

1:10@A1 1:20@A3

Job No.

Drawing No.

A304

Drawn

Checked

Issue Date



17/4/2007

Status

BC

Revision

0

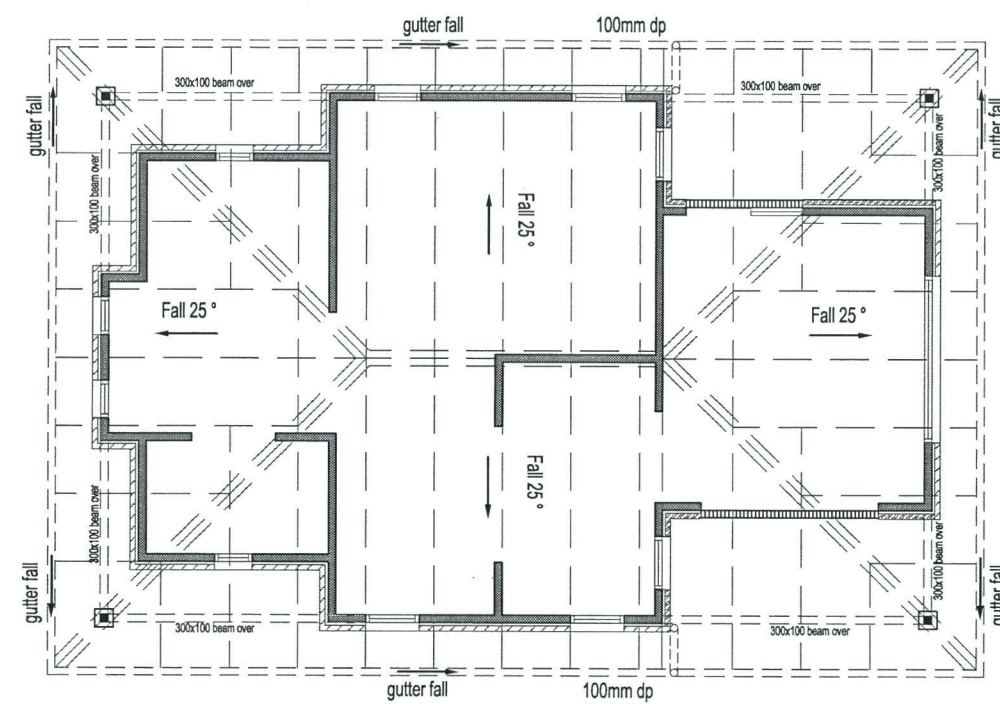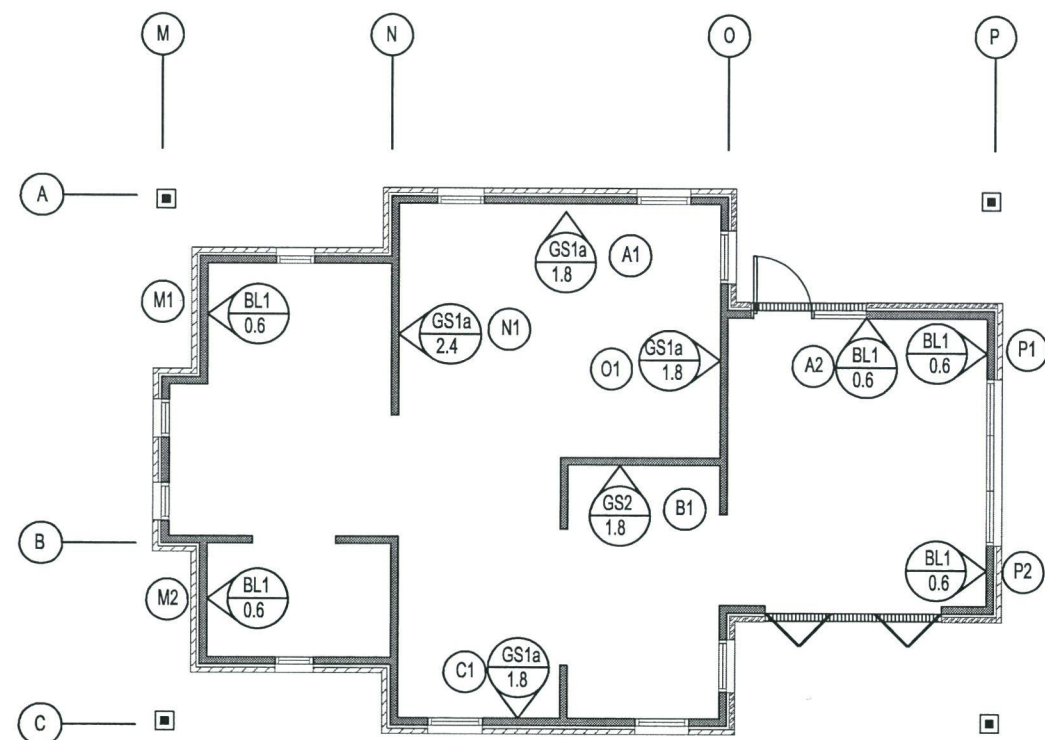[illegible]

**JIREH**  
DESIGN LTD [www.ttay.com](http://www.ttay.com)

**TONY TAY GROUP BUILDING**  
LEVEL 1, 540 GT SOUTH ROAD, GREENLANE, PO BOX 88220 NEWTON  
AUCKLAND, NZ PHONE: +64 9 580 1750 FAX: +64 9 580 3180

Client

TONY TAY GROUP

Job

KARAPIRO HEALTH SPA  
SINGLE CHALET

Drawing Title

CHALET TYPE B

Bracing and Roof Framing Plan

Scales	
1:50@A1	1:100@A3

Job No.	Drawing No.
	A305

Drawn	Checked	Issue Date 17/4/2007
-------	---------	-------------------------

Status	Revision
BC	0







Technical drawing of a window unit. The drawing shows a rectangular frame containing four vertical rectangular panes. Each pane is divided by a diagonal line from the top-left to the bottom-right. The overall width is dimensioned as 2400 and the overall height as 2100. The drawing is a line art representation with no shading.

D02

Technical drawing of a door. The width is dimensioned as 1800 and the height as 2100. A handle symbol is shown on the right side of the door.

D03

Technical drawing of a door. The width is dimensioned as 1700 and the height as 2100. An arrow points to the right, indicating the door's swing.

D04

Interior  
Glass Sliding door.  
Aluminium outer frame and  
aluminium frame



W02

W03, W04, W05  
W10, W11, W12

W06,W09

W07,W08

Combination Fixed  
and Grilled Window  
3M film to clear glass,  
refer to spec.

Drawn	Checked	Issue Date 17/4/2007
Status BC		Revision 0